


NOTE

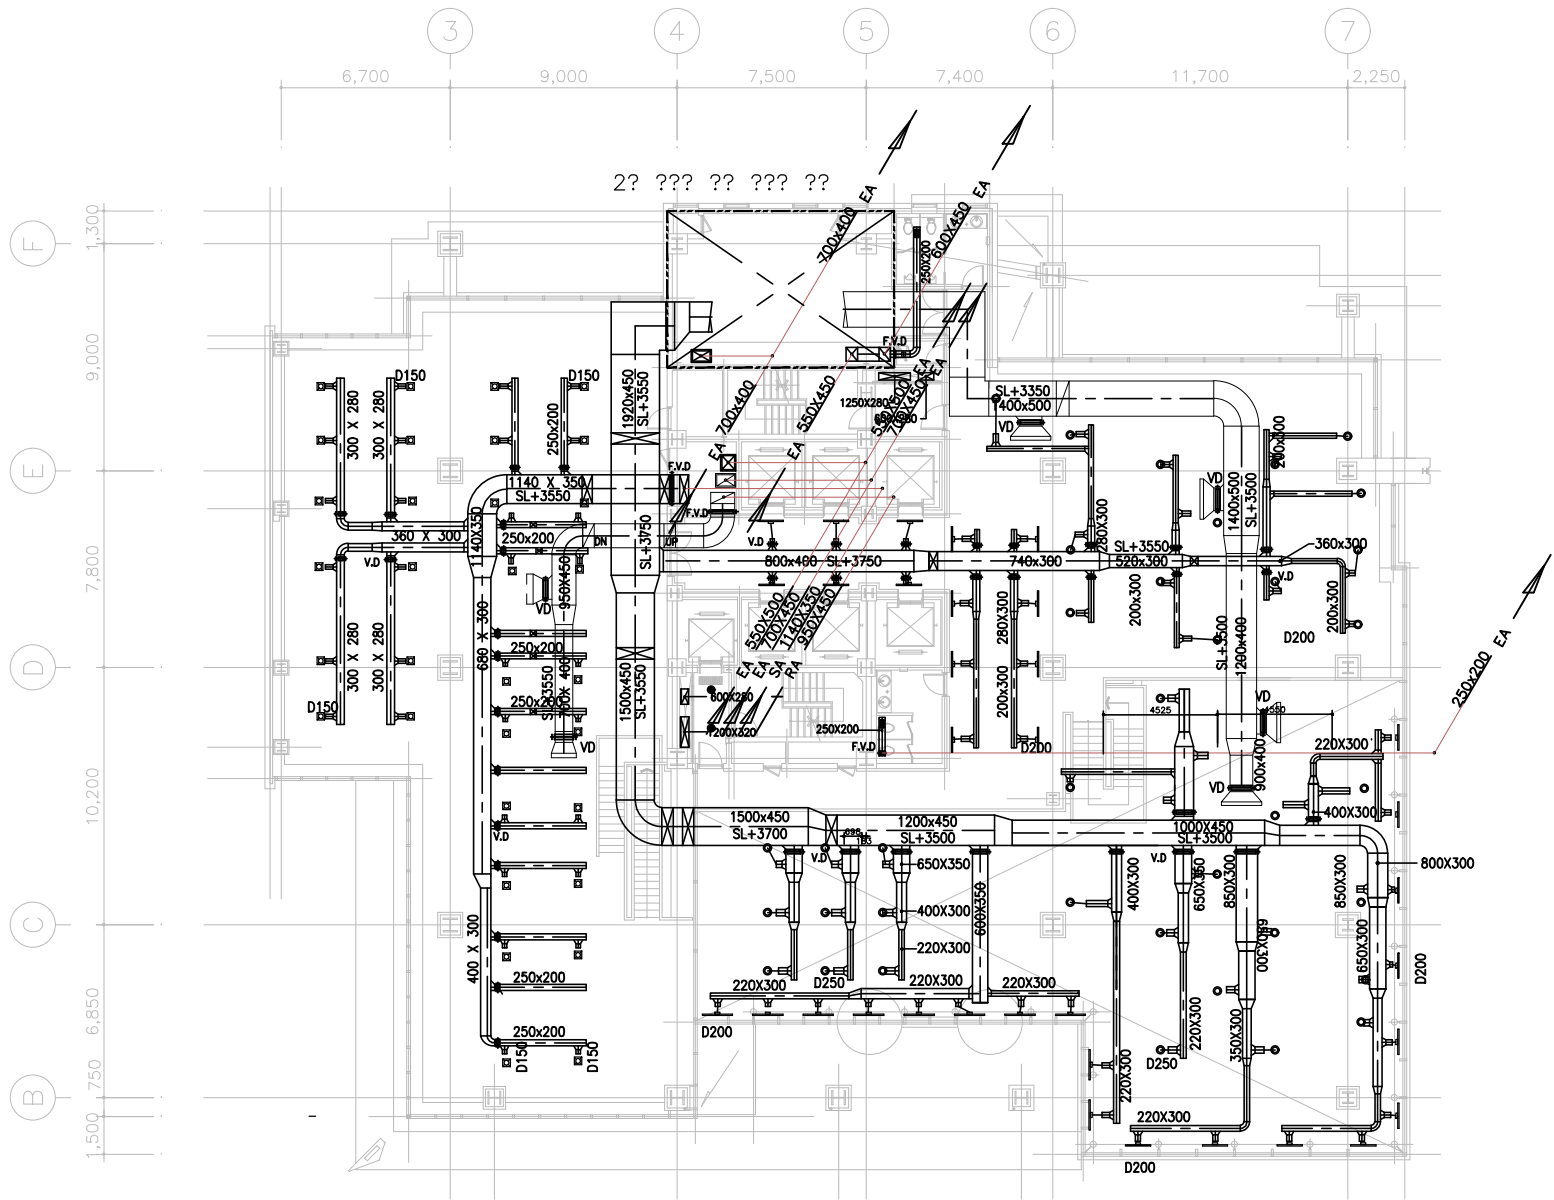

- 환장실(여)

EA	
GRILLE	x 1 EA
종량 :	400 CMH
크기 :	250X200
* FLEX DUCT HOSE	
DIA 200 으로 연결	
- 환장실(남)

EA	
GRILLE	x 1 EA
종량 :	400 CMH
크기 :	250X200
* FLEX DUCT HOSE	
DIA 200 으로 연결	
- 청소도구실

EA	
	x 1 EA
종량 :	100 CMH
크기 :	150X150
* FLEX DUCT HOSE	
DIA 125 으로 연결	

역표기구 일람표

ZONE		? ?	SUPPLY TERMINAL						RETURN TERMINAL						??? ?? O.A	??? ?? E.A	REMARKS	
AHU NO.	ROOM NAME		??? (CMH)	TYPE	??	SIZE			??? (CMH)	TYPE	??	SIZE						
						CMH/EA	NECK(Ø)	OVERALL				CMH/EA	NECK(Ø)	OVERALL				
AHU-02	???? ? ??	2 ? ? ?	12,000	??? ??? PAN DIFF.	32	375	175	300X300	12,000	??	????	????	??	??	(? 60MM 40M ??)			
		EXFILTRATION															450	
AHU-03		2? ???	5,075	ROUND PAN DIFF.	14	363	200	250 A										
		2? ???	5,075	T-LINE DIFF.	14	362	200	50x1000										
		?? OPEN ??	20,000	NOZZLE DIFF.	25	800	250	300 A										
		2? ?? ??	7,000	T-LINE DIFF.	20	350	200	50x1000										
		? ? ?															900	
		EXFILTRATION															500	

1
M 2층 공조덕트 평면도
월잡 : 1/150

DRN	???	9.28	 한길 서울특별시 중구 남대문로 5가 541 대우빌딩 17층 TEL. 3708-4571 FAX. 3708-4619, 4618		
DES					
CHK					
APP.					
P.M					
CLINT APP.	SIGN	DATE	SCALE 1/150	DRAWING NO. M-109	DB NAME

PROJECT NAME
남대문 대우빌딩 신축공사

BUILDING NAME

DRAWING NAME
2층 공조덕트 평면도